




LEGEND



SCHEME EXTENTS 

EXISTING SURFACE WATER / COMBINED SEWER PIPE 

EXISTING GULLY 

NOTES

- EXISTING DRAINAGE REGIME TO BE VERIFIED BY FURTHER SITE INVESTIGATIONS

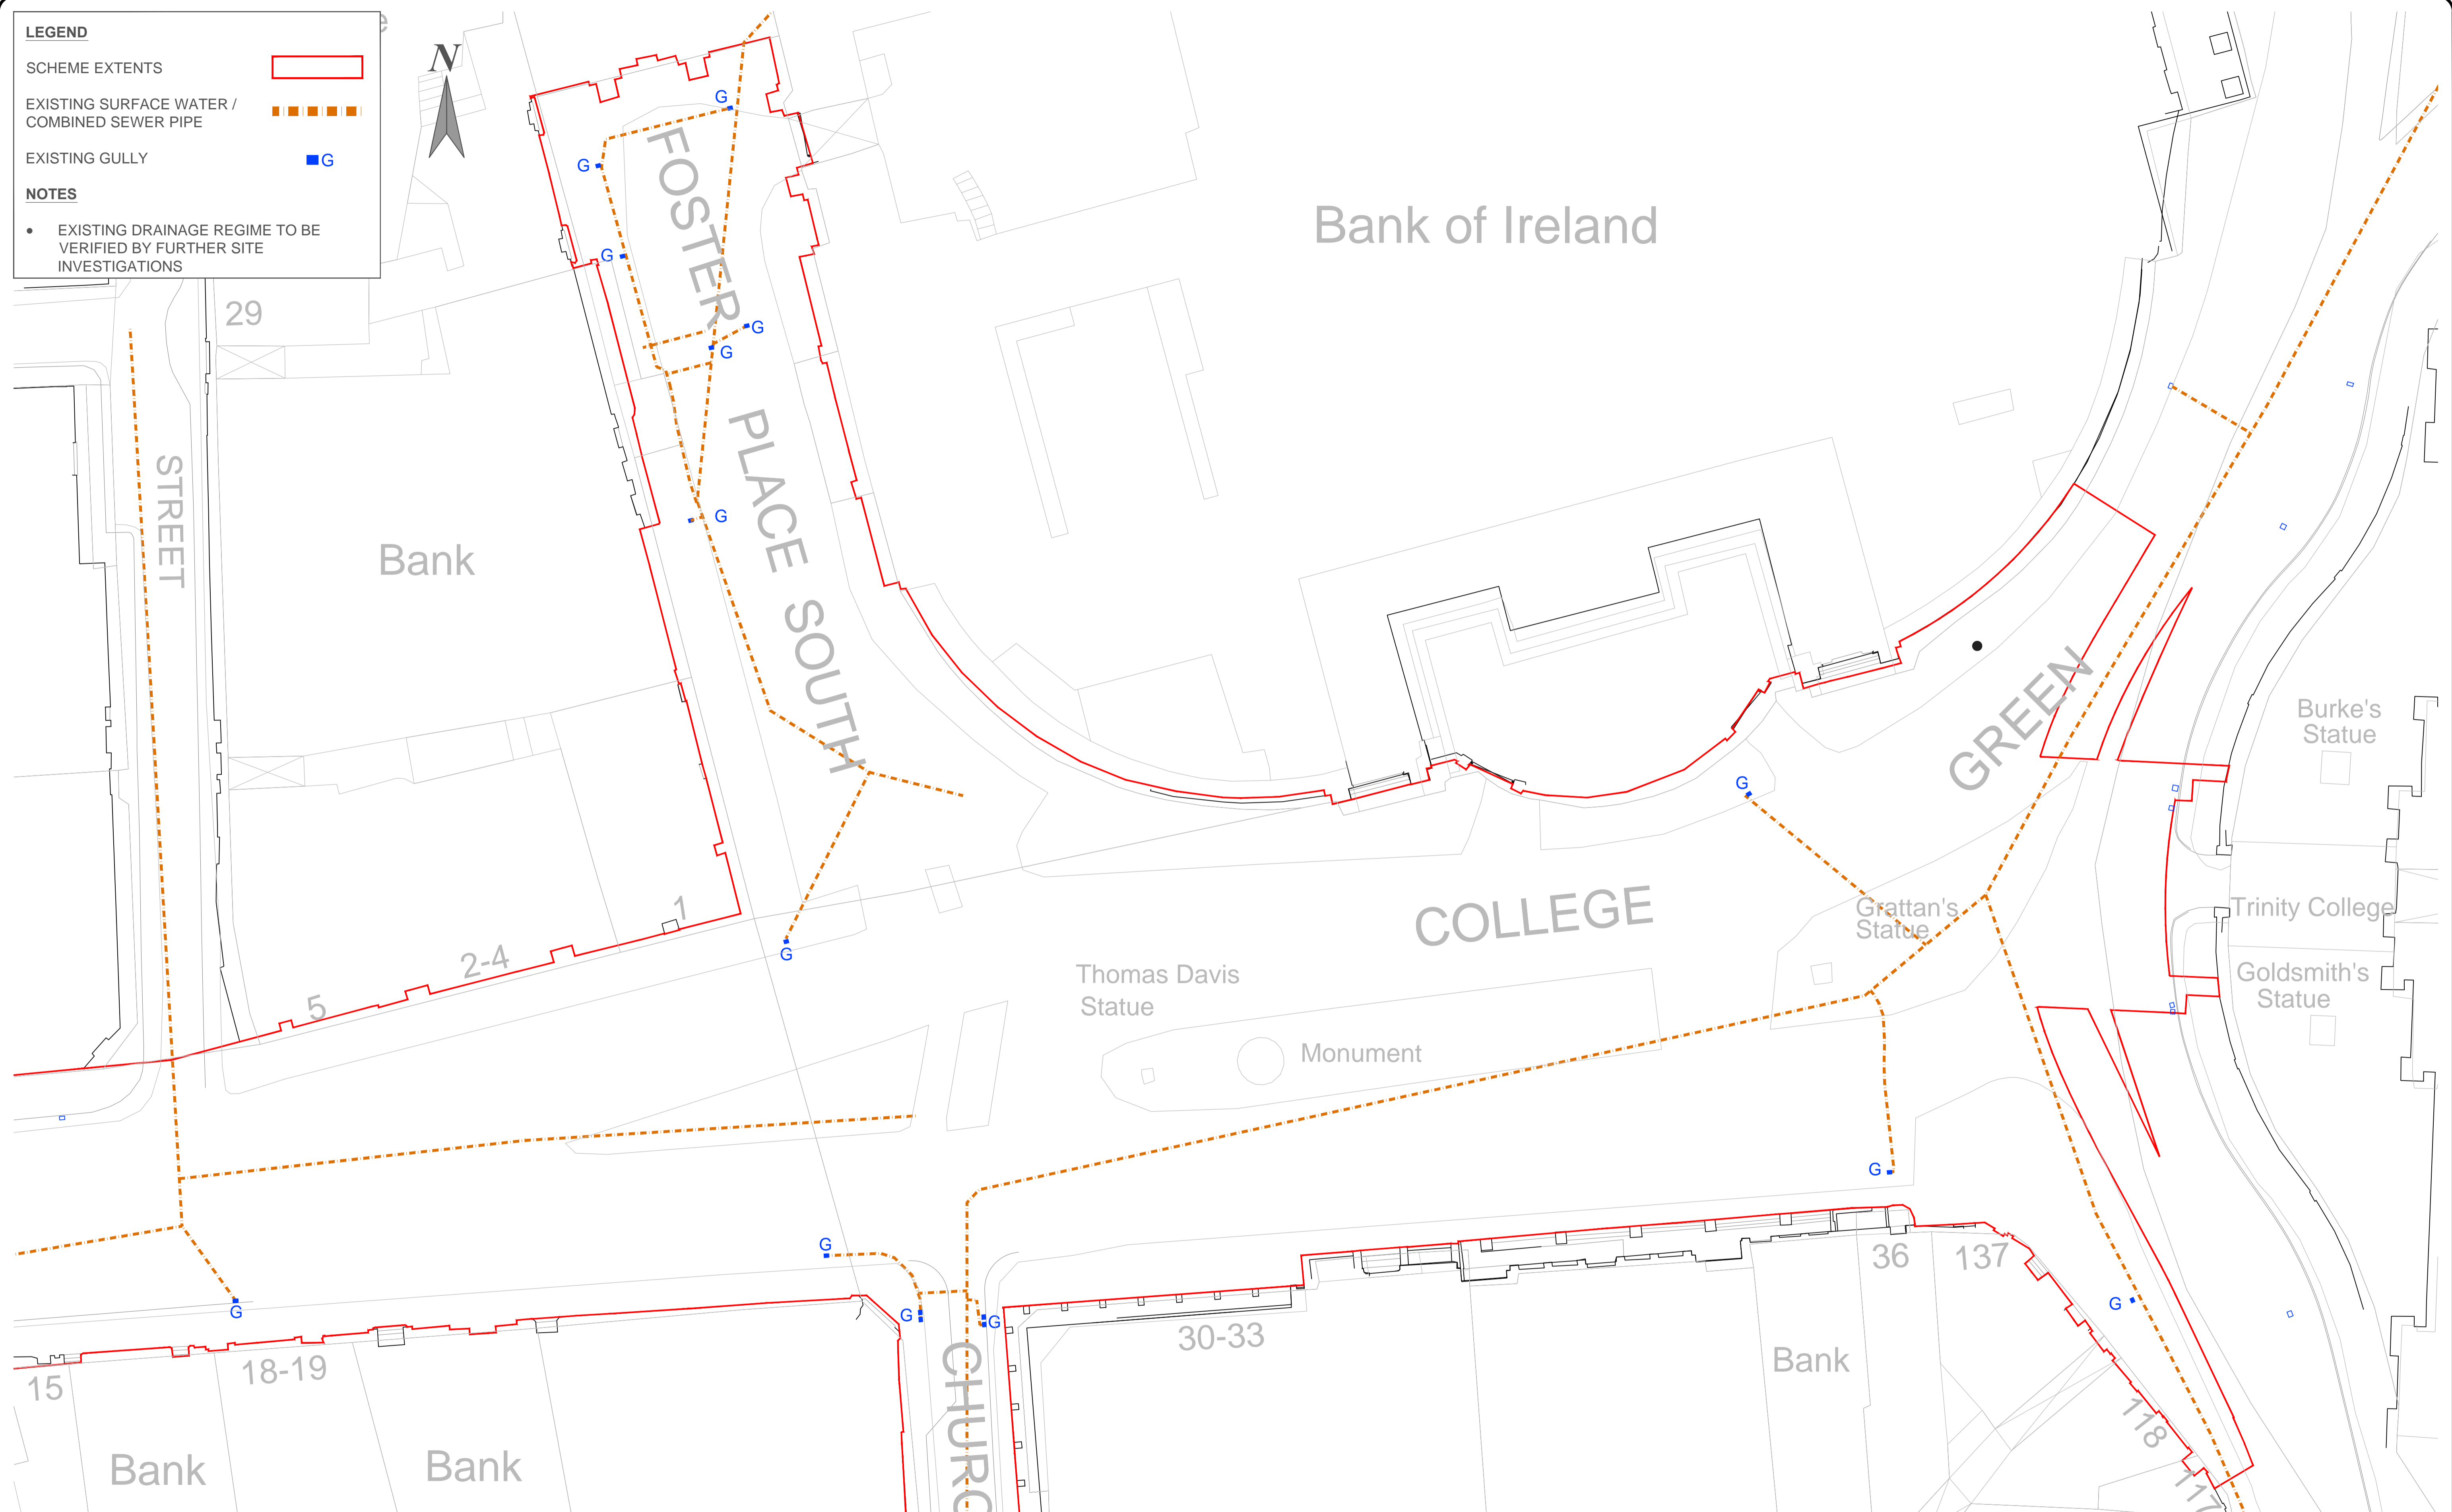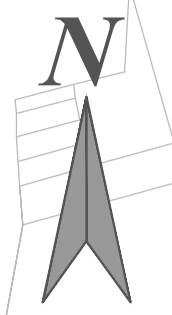

No.	Revision Stage	Date	By	Chk'd	App'd
	PRELIMINARY				
	APPROVAL				
	TENDER				
	CONSTRUCTION				



Arena House, Arena Road,
Sandyford, Dublin 18.
Tel : +353 1 294 0800
Fax : +353 1 294 0820
e-mail : info@rod.ie
Website : www.rod.ie

Designed: DN Checked: EOC Approved: SMG Status: PRELIMINARY

Project Title COLLEGE GREEN STREETScape IMPROVEMENT			
Drawing Title Section 4.12 - Infrastructure & Services Existing Drainage Layout			
Drawn: CPG	Job No: 17.110	Drawing No: 04-500-DR-002	Rev: -
Scale: (A1) 1:250 @ A1, 1:500 @ A3	Date: May '17		